



2/19/2025 3:39:35  
 Architect: DORR, INC., NY, Tappan, NY 10987  
 Project: 1456 ROUTE 303, TAPPAN, NY 10987

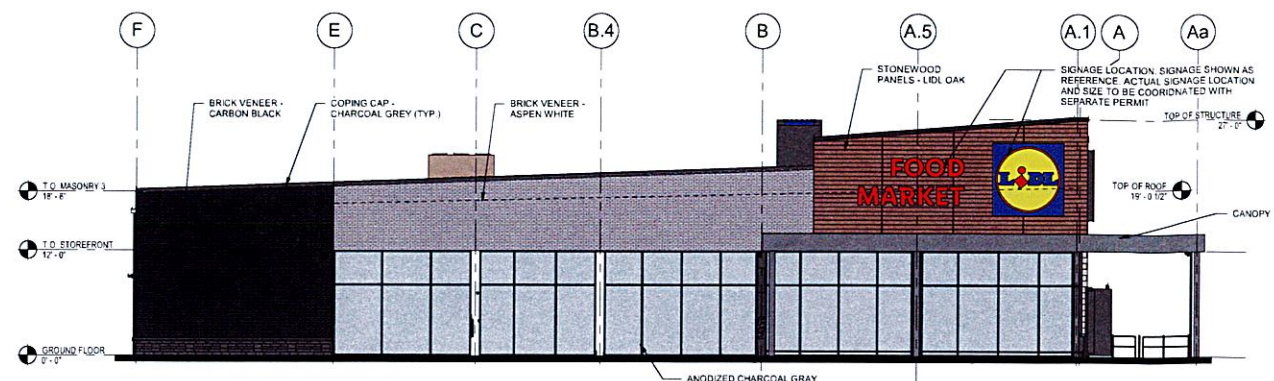


**1 LEFT ELEVATION (WEST)**  
SCALE: 1/8" = 1'-0"


EXTERIOR FINISH SCHEDULE					
FINISH DESCRIPTION	MANUFACTURER	FINISH	COLOR	NOTES	NAME
BRICK COLOR B	GLEN GERY	MODULAR	ASPEN WHITE	GROUT ARGOS - WHITE N	BAKERY FREEZER
BRICK COLOR A	GLEN GERY	MODULAR	CARBON BLACK	GROUT ARGOS - REGULAR GRAY SLATE	TECHNICAL ROOM
STONE	GLEN GERY	GLEN RIDGE	GRANITE	GROUT ARGOS - REGULAR GRAY SLATE	IT ROOM
WOOD LOOKING PHENOLIC PANELS	STONEWOOD	CUSTOM	LIDL OAK		WELLNESS ROOM
METALS - FASCIA GUTTERS - DOWNSPOUTS	ATAS	PNDF	CHARCOAL GREY		OFFICE
CMU COLOR A	OLDCASTLE	SPLITFACE	PEARL MIST	GROUT ARGOS - WHITE N	VESTIBULE
CMU COLOR B	OLDCASTLE	SPLITFACE	SLATE GREY	GROUT ARGOS - REGULAR GRAY SLATE	STAGING
SILL	OLDCASTLE	SPLITFACE	CHARCOAL	GROUT ARGOS - REGULAR GRAY SLATE	OFFICE
STOREFRONT SYSTEM - FRAME/WINDOWS	KAWNEER	SEE SPECS	CHARCOAL GREY		BAKERY
ALUMINUM FRAMED SLIDING DOORS	ASSA ABLOY	SEE SPECS	CHARCOAL GREY		SPRINKLER RISER

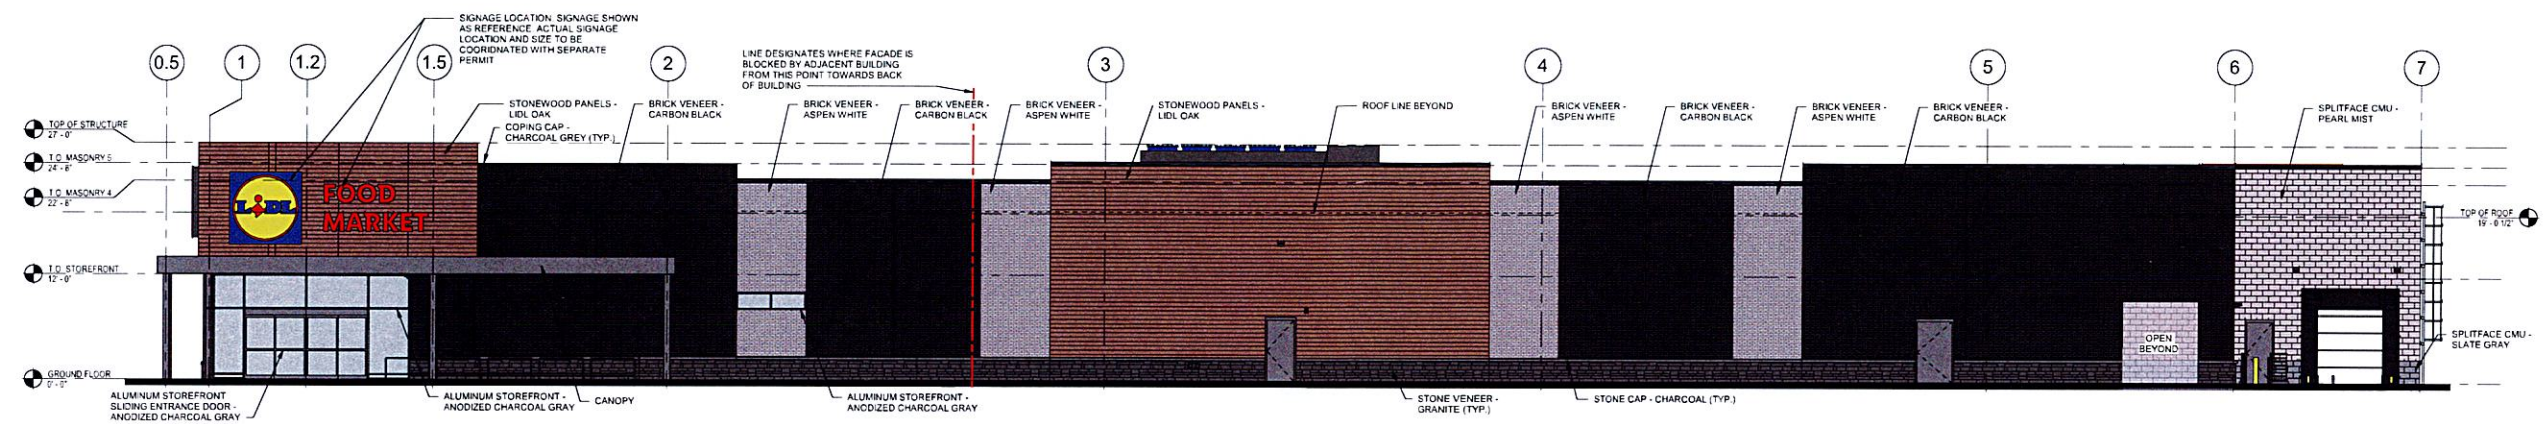

**2 FRONT ELEVATION (SOUTH)**  
SCALE: 1/8" = 1'-0"

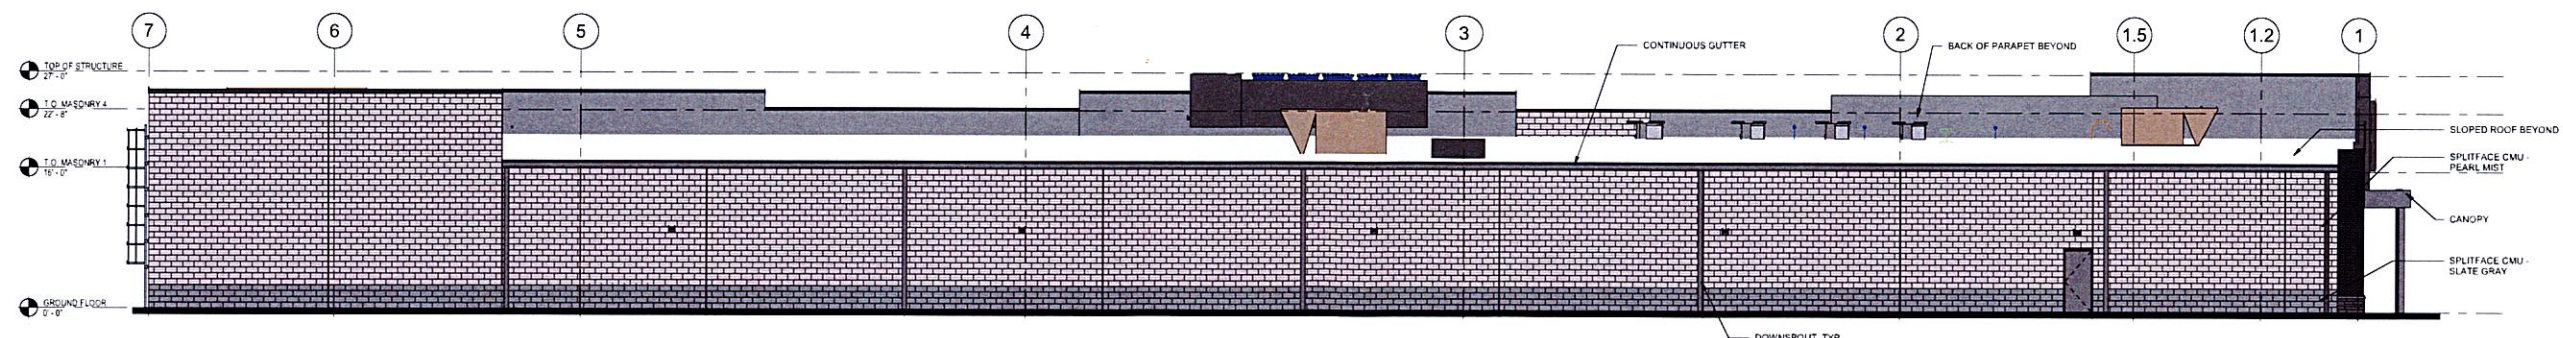

**3 BACK ELEVATION (NORTH)**  
SCALE: 1/8" = 1'-0"

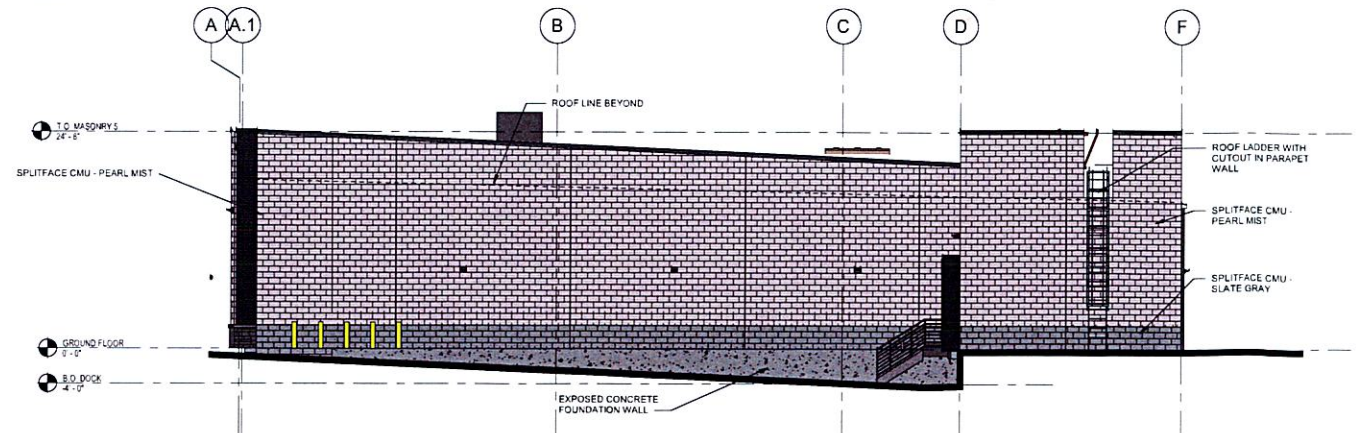

**4 RIGHT ELEVATION (EAST)**  
SCALE: 1/8" = 1'-0"

DATE	ISSUED FOR	REV
2024-10-16	COLOR ELEVATIONS	
2025-02-10	COLOR ELEVATIONS MEETING COMMENTS	

This drawing has been prepared solely for the use of the LIDL US, LLC and there are no representations of any kind made by NORR to any party with whom NORR has not entered into a contract.

This drawing shall not be used for construction purposes until the seal appearing hereon is signed and dated by the Architect or Engineer.



Consultants	BOHLER
Civil	N/A
Landscape	N/A
Architecture	NORR
Structural	NORR
Mechanical	NORR
Electrical	NORR

Seal(s)

**NORR**  
150 W. Jefferson Avenue, Suite 1300  
Detroit, MI, US 48226  
nor.com

Project Manager	TRERI D	BIM Lead	RANDY F.
Design Lead	ANTHONY G.	Draw	ANTHONY G.
Project Leader	RICARDO A.	Checked	SARAH G.

LIDL US, LLC

Project  
1456 LIDL - TAPPAN, NY  
3-58 NYS ROUTE 303  
TAPPAN, NY 10983

Drawing Title  
EXTERIOR COLORED ELEVATIONS

Scale	1/8" = 1'-0"
Project No.	JCDT21-0143
Drawing No.	SD200

RECEIVED  
 FEB 18 2025  
 TOWN OF ORANGETOWN  
 BUILDING DEPARTMENT

NOT FOR CONSTRUCTION